



N. P. 1363
6-24

NORTHERN PACIFIC RAILWAY COMPANY
AUTHORITY FOR EXPENDITURE

SUPERINTENDENT No.
No.

Tax DEPT. No. 768
ENGINEERING DEPT. No.

1931
YEAR 1931

A. F. E. NO. 12

Dakota Div.

Eastern

DISTRICT STATE Nor. Dak. VAL. SEC. No. 1.
BRANCH

AUTHORITY IS REQUESTED FOR A NET EXPENDITURE OF \$530.00
Accounting distribution as follows: (Distribution to be made in General Office.)

Cost of property retired	Operating Expenses	Profit and Loss	Net Operating Expenses	Net Profit and Loss
Value of salvage				
Incidental costs				
Total to Operating Expenses				
Total to Profit and Loss				
To Material and Supplies				
To Bills for Collection				
To Other Accounts				
Net charge to investment account—Additions and Betterments				
Total of distribution				

Budget reference: In budget

Joint facility contract reference:

The location is partly on this company's property. To secure rights, it will be necessary
Location: Bismarck

Class of Work: No. 28

Title Assessment for storm water sewer in 9th St., Dist. #18.
and

Reason: This R.F.A. is made to cover an assessment levied against our right of way as its share of the cost of a storm water sewer constructed in 9th St. as shown on attached blue print. The total cost of this improvement was \$1312.61. Of this sum the State Highway Commission contributed \$252.38; the balance, \$1060.23, was assessed by the special assessment commission against the property in the district in accordance with its judgment as to benefits received. Our assessment has been checked at Bismarck and is equitable and correct.

Mr. Watson advised of amounts applicable to lessees.
Blue print attached.

Work commenced Aug. 27, 1929.
Work completed Sept. 13, 1929.

Checked as to property description J. L. Watson 1/6/1931

Work done by ~~contract~~ under charge of city.

Accounting to concentrate in the office of tax commissioner.

Signature and Title: E. A. McCarry
Tax Commissioner.

Checked and Entered
President's Office

Date Jan. 5, 1931.

APPROVED:

O. K. H. A. Tolson
Tax Agent.

General Superintendent

Asst. Chief Engr. or Engr. Maint. of Way

General Manager

Mech. Supt., Supt. Telg. or Signal Engr.

Chief Engineer

Per Comptroller

Date of Final Approval

Vice President


Form No. 1345 issued

COMPTROLLER'S RECORD OF NOTICE OF APPROVAL AND OF COMPLETION

19 Work begun

19 Work finished

19

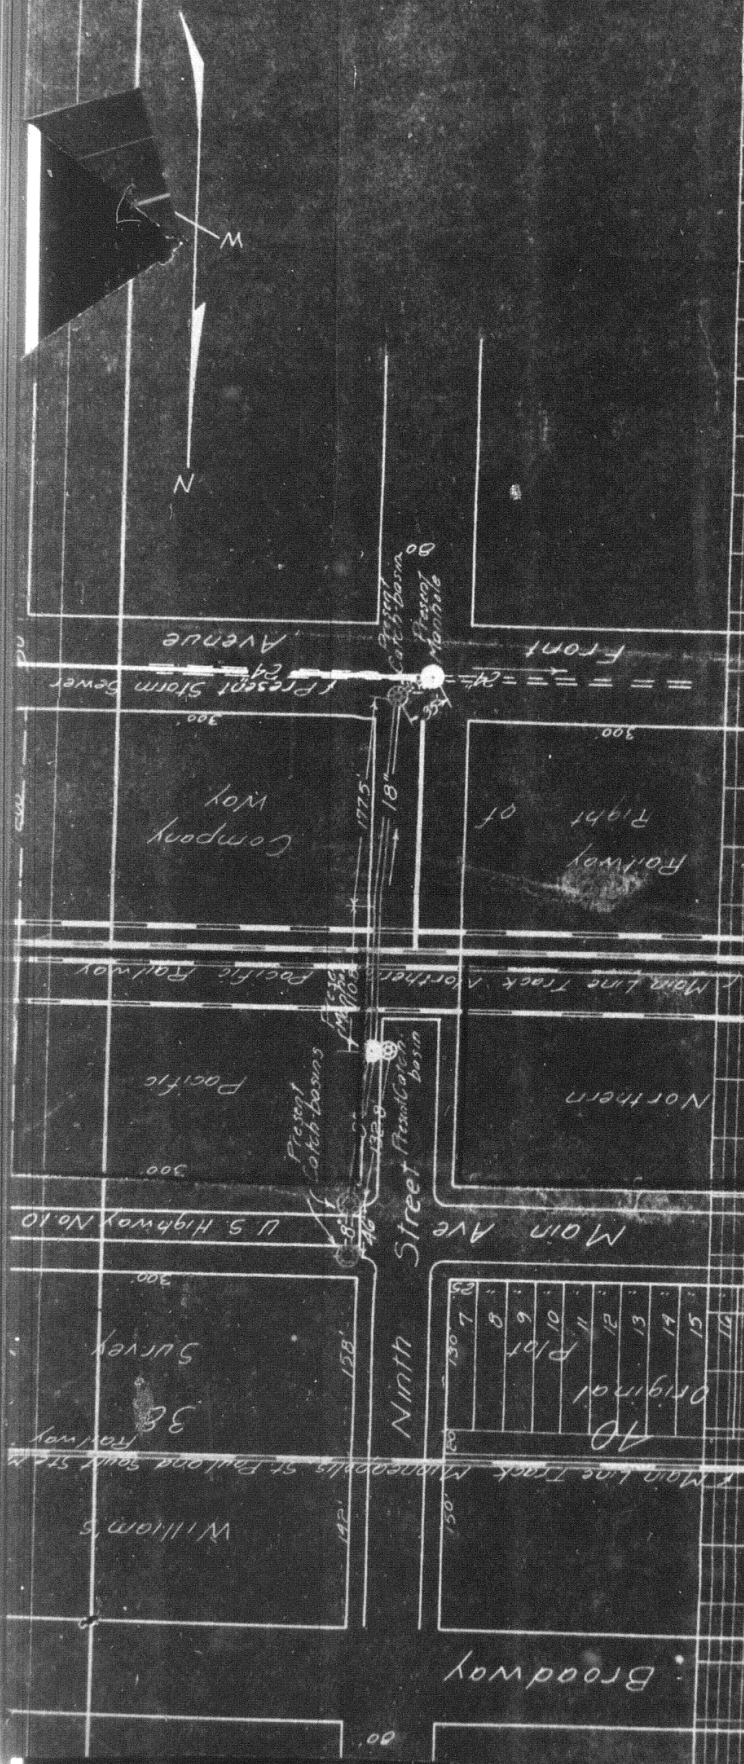

Plan and Profile
of Storm Water Sewer
on Ninth Street
Main Avenue to Front Avenue
in Sewer Improvement District
Number Fifteen
Bismarck North Dakota

Vertical Scale = 1" = 10'
Horizontal Scale = 1" = 100'
Bismarck, N.D. F.R. Atkinson
July 20, 1929 City Engineer